


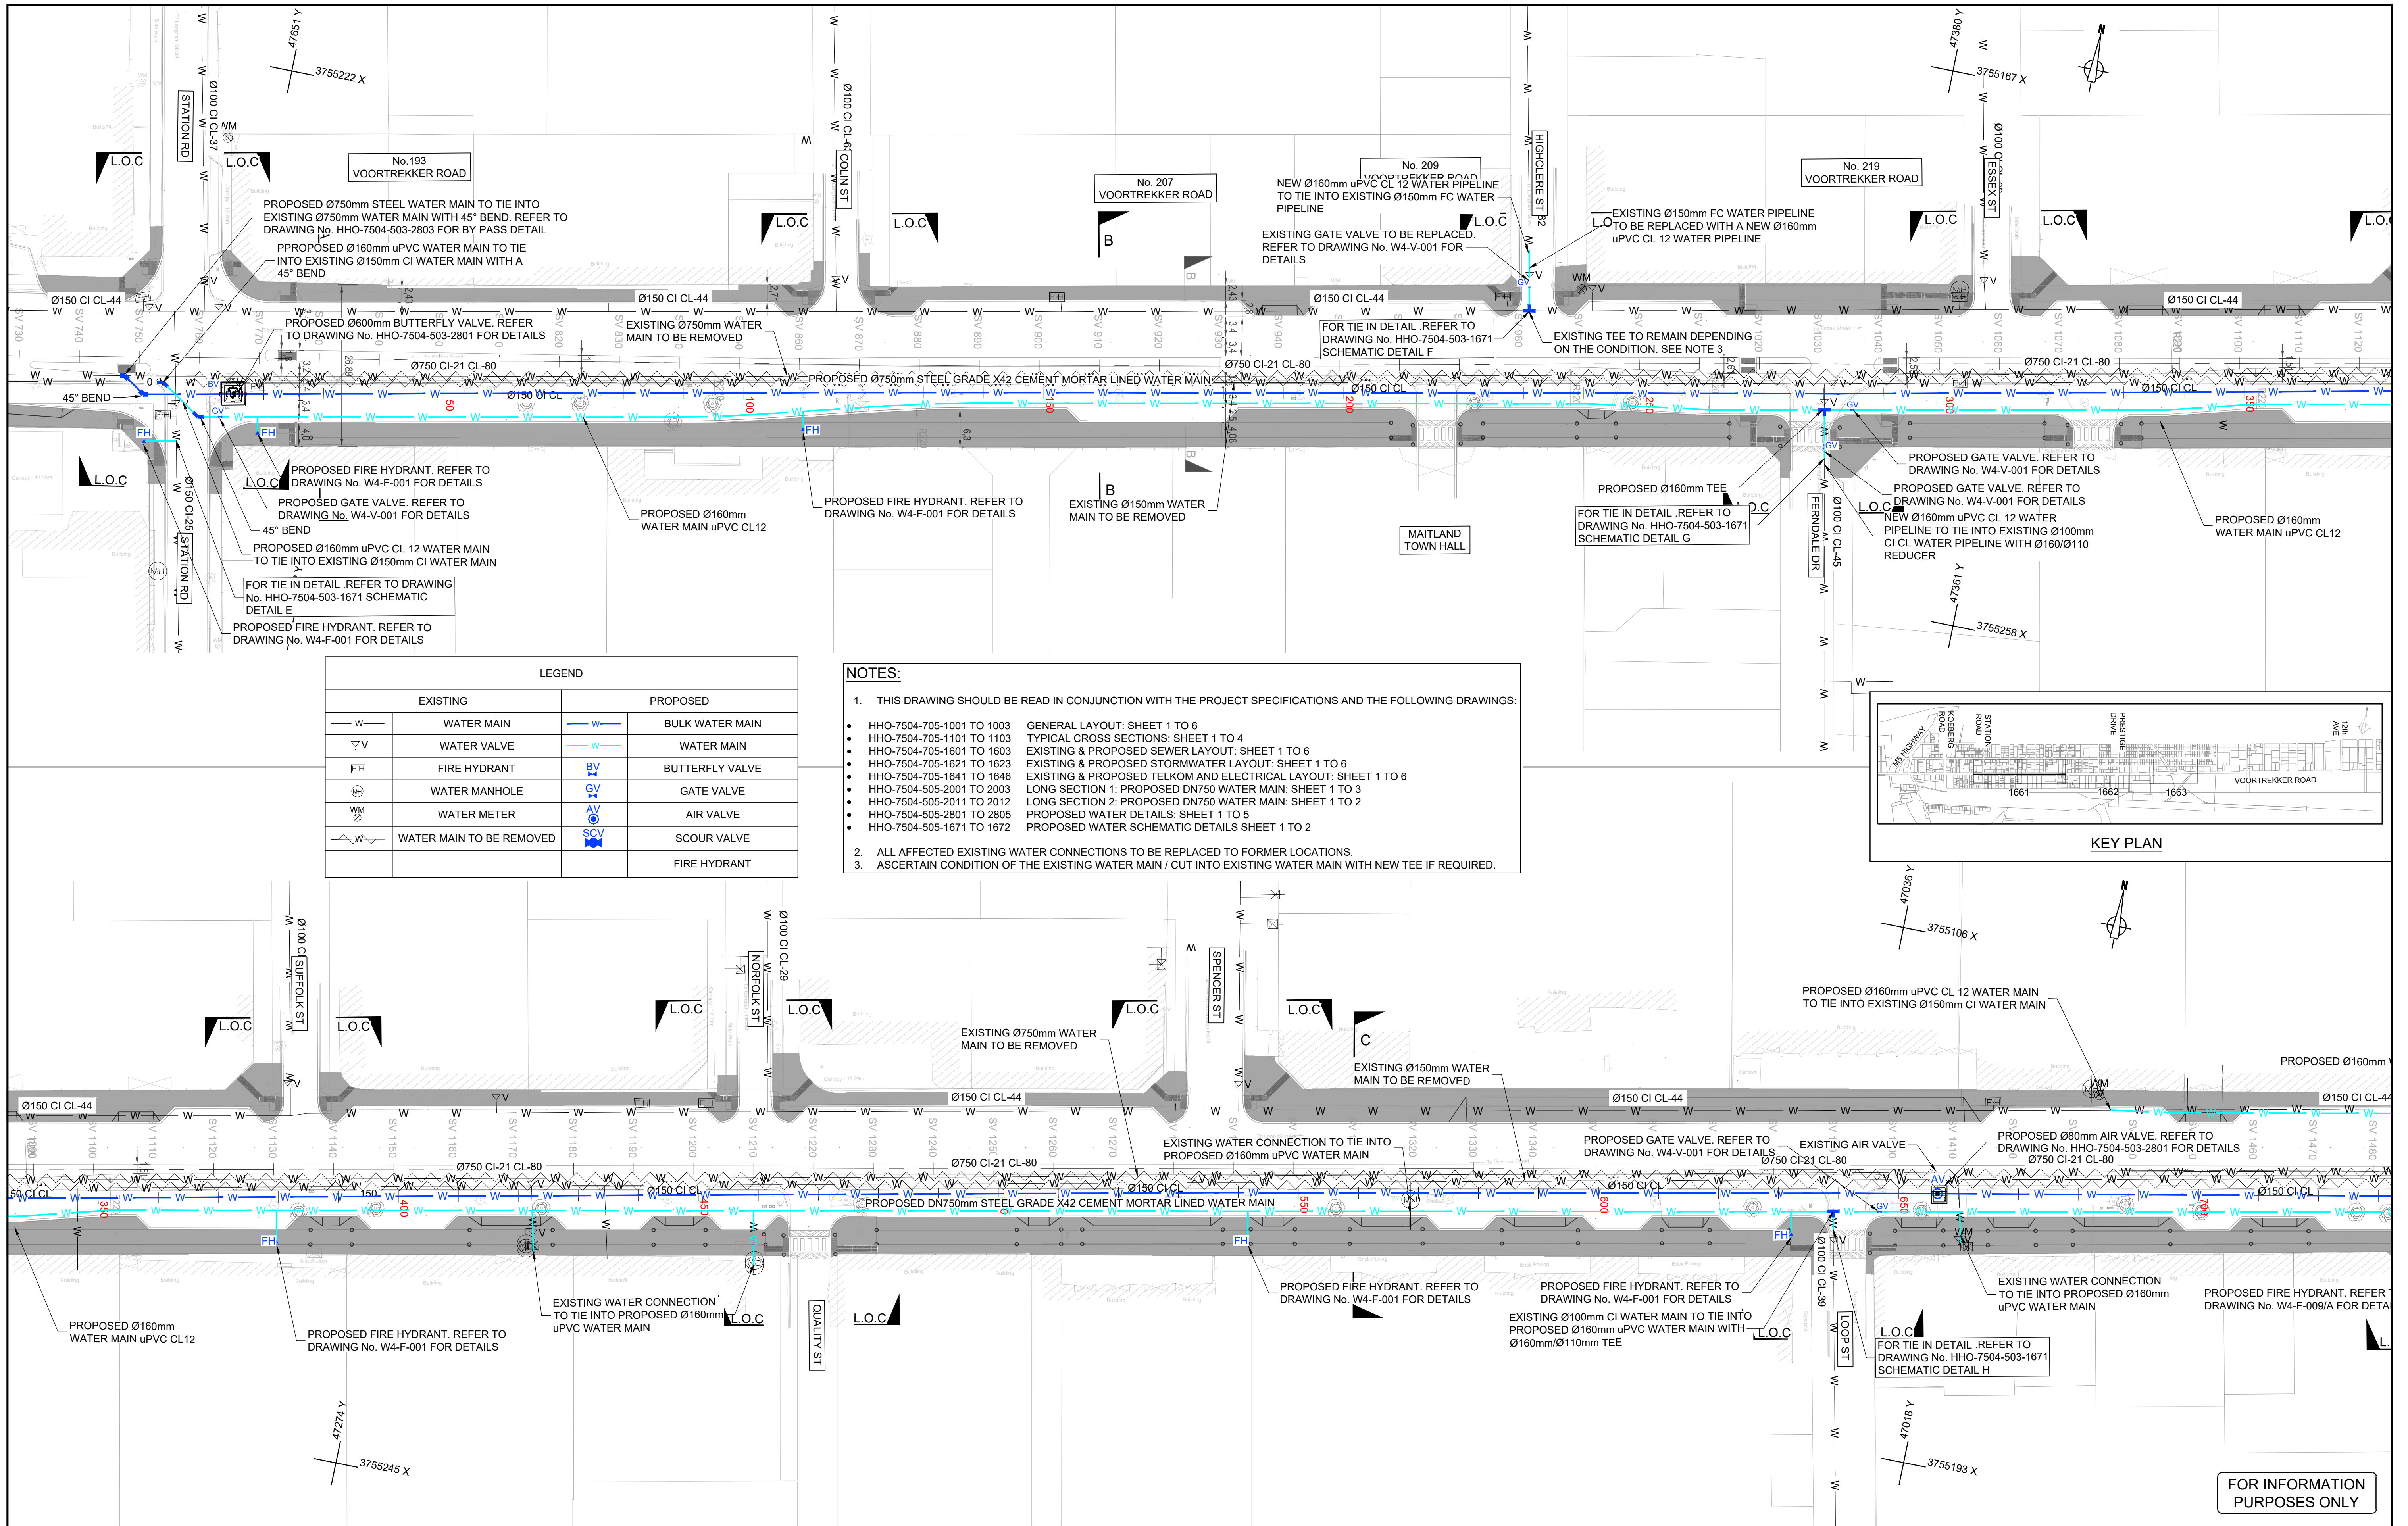

LEGEND			
EXISTING		PROPOSED	
— W —	WATER MAIN	— W —	BULK WATER MAIN
▽ V	WATER VALVE	— W —	WATER MAIN
FH	FIRE HYDRANT	BY	BUTTERFLY VALVE
WM	WATER MANHOLE	GV	GATE VALVE
W M	WATER METER	AV	AIR VALVE
— W —	WATER MAIN TO BE REMOVED	SCV	SCOUR VALVE
			FIRE HYDRANT

- NOTES:
- THIS DRAWING SHOULD BE READ IN CONJUNCTION WITH THE PROJECT SPECIFICATIONS AND THE FOLLOWING DRAWINGS:
 - HHO-7504-705-1001 TO 1003 GENERAL LAYOUT: SHEET 1 TO 6
 - HHO-7504-705-1101 TO 1103 TYPICAL CROSS SECTIONS: SHEET 1 TO 4
 - HHO-7504-705-1601 TO 1603 EXISTING & PROPOSED SEWER LAYOUT: SHEET 1 TO 6
 - HHO-7504-705-1621 TO 1623 EXISTING & PROPOSED STORMWATER LAYOUT: SHEET 1 TO 6
 - HHO-7504-705-1641 TO 1646 EXISTING & PROPOSED TELKOM AND ELECTRICAL LAYOUT: SHEET 1 TO 6
 - HHO-7504-505-2001 TO 2003 LONG SECTION 1: PROPOSED DN750 WATER MAIN: SHEET 1 TO 3
 - HHO-7504-505-2011 TO 2012 LONG SECTION 2: PROPOSED DN750 WATER MAIN: SHEET 1 TO 2
 - HHO-7504-505-2801 TO 2805 PROPOSED WATER DETAILS: SHEET 1 TO 5
 - HHO-7504-505-1671 TO 1672 PROPOSED WATER SCHEMATIC DETAILS SHEET 1 TO 2
 - ALL AFFECTED EXISTING WATER CONNECTIONS TO BE REPLACED TO FORMER LOCATIONS.
 - ASCERTAIN CONDITION OF THE EXISTING WATER MAIN / CUT INTO EXISTING WATER MAIN WITH NEW TEE IF REQUIRED.

THIS DOCUMENT HAS BEEN PREPARED IN ACCORDANCE WITH THE SCOPE OF HHO'S APPOINTMENT. HHO ACCEPTS NO LIABILITY FOR ANY USE OF THIS DOCUMENT OTHER THAN BY ITS CLIENT AND ONLY FOR THE PURPOSES FOR WHICH IT WAS PREPARED AND PROVIDED. © HHO 2018

DO NOT SCALE FROM THIS DRAWING. ONLY WRITTEN DIMENSIONS SHALL BE USED. DIMENSIONS AND LEVELS ARE TO BE VERIFIED ON SITE BY THE CONTRACTOR BEFORE COMMENCING ANY WORK. ANY DISCREPANCIES ARE TO BE REPORTED TO THE ENGINEER FOR VERIFICATION.

ON ORIGINAL

Rev	Date	Prepared by	Checked by	Approved by	ISSUED FOR INFORMATION	Consultant Revision Details	Status
A	07/2026	MM	TR	PF			IFI

Client

CITY OF CAPE TOWN
ISIXEKO SASEKAPA
STAD KAAPSTAD

Making progress possible. Together.

Client Approval

Consultant Name
PAUL FARIA

Consultant Signature

Date

PR Eng No.
20080318

Project Title
VOORTREKKER ROAD CORRIDOR
PHASE 1B

Drawing Title
EXISTING & PROPOSED
WATER LAYOUT
SHEET 1 OF 3

Client Number
CPX.0010465


Scale
1:500

Drawing Number
HHO-7504-505-1661

Rev
A


14 FLOOR, THE TOWERS SOUTH,
2 HERTZOG BOULEVARD,
CAPE TOWN, SOUTH AFRICA,
8001

TEL: +27 21 425 2870
WEB: www.hho.co.za
EMAIL: enquiries@hho.co.za

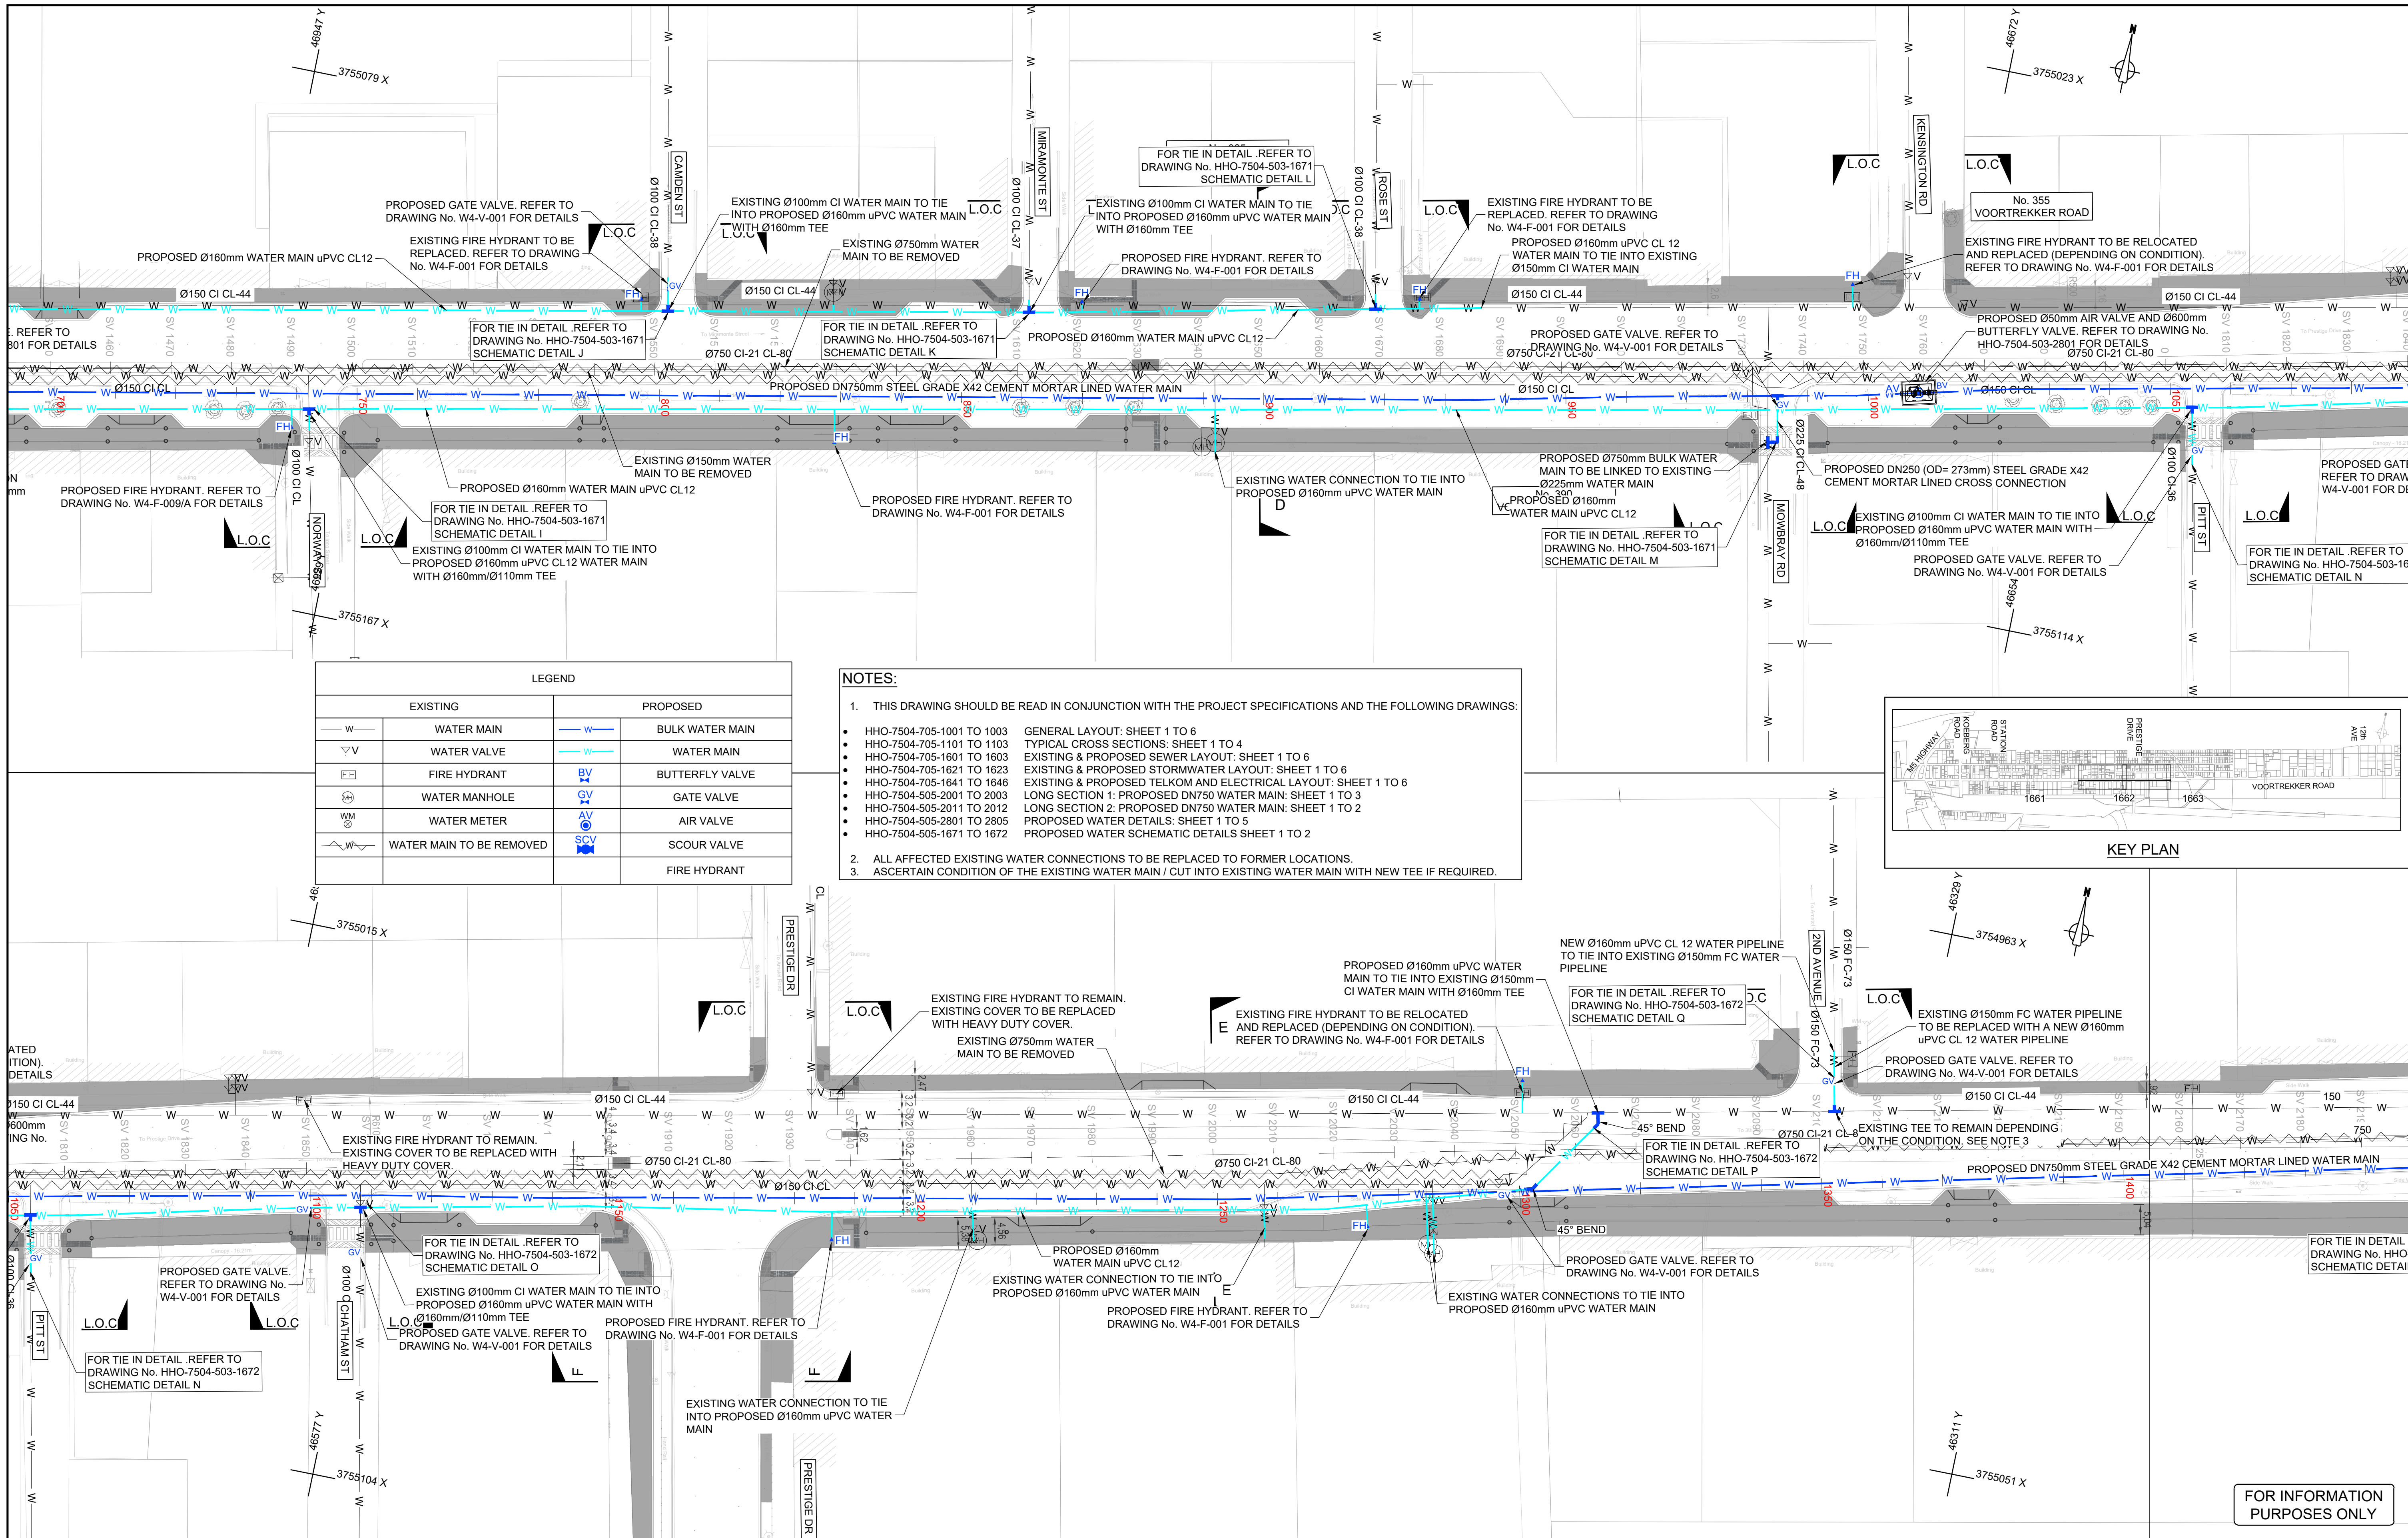


LEGEND			
EXISTING		PROPOSED	
— W —	WATER MAIN	— W —	BULK WATER MAIN
▽ V	WATER VALVE	— W —	WATER MAIN
FH	FIRE HYDRANT	BV	BUTTERFLY VALVE
⊙	WATER MANHOLE	GV	GATE VALVE
⊙	WATER METER	AV	AIR VALVE
— W —	WATER MAIN TO BE REMOVED	SCV	SCOUR VALVE
			FIRE HYDRANT

- NOTES:
- THIS DRAWING SHOULD BE READ IN CONJUNCTION WITH THE PROJECT SPECIFICATIONS AND THE FOLLOWING DRAWINGS:
 - HHO-7504-705-1001 TO 1003 GENERAL LAYOUT: SHEET 1 TO 6
 - HHO-7504-705-1101 TO 1103 TYPICAL CROSS SECTIONS: SHEET 1 TO 4
 - HHO-7504-705-1601 TO 1603 EXISTING & PROPOSED SEWER LAYOUT: SHEET 1 TO 6
 - HHO-7504-705-1621 TO 1623 EXISTING & PROPOSED STORMWATER LAYOUT: SHEET 1 TO 6
 - HHO-7504-705-1641 TO 1646 EXISTING & PROPOSED TELKOM AND ELECTRICAL LAYOUT: SHEET 1 TO 6
 - HHO-7504-505-2001 TO 2003 LONG SECTION 1: PROPOSED DN750 WATER MAIN: SHEET 1 TO 3
 - HHO-7504-505-2011 TO 2012 LONG SECTION 2: PROPOSED DN750 WATER MAIN: SHEET 1 TO 2
 - HHO-7504-505-2801 TO 2805 PROPOSED WATER DETAILS: SHEET 1 TO 5
 - HHO-7504-505-1671 TO 1672 PROPOSED WATER SCHEMATIC DETAILS SHEET 1 TO 2
 - ALL AFFECTED EXISTING WATER CONNECTIONS TO BE REPLACED TO FORMER LOCATIONS.
 - ASCERTAIN CONDITION OF THE EXISTING WATER MAIN / CUT INTO EXISTING WATER MAIN WITH NEW TEE IF REQUIRED.

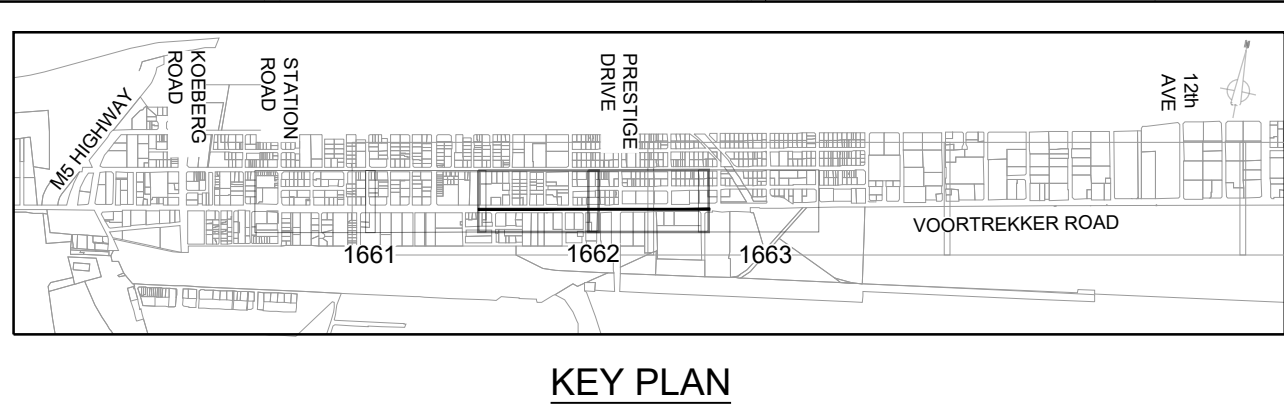


THIS DOCUMENT HAS BEEN PREPARED IN ACCORDANCE WITH THE SCOPE OF HHO'S APPOINTMENT. HHO ACCEPTS NO LIABILITY FOR ANY USE OF THIS DOCUMENT OTHER THAN BY ITS CLIENT AND ONLY FOR THE PURPOSES FOR WHICH IT WAS PREPARED AND PROVIDED. © HHO 2018 DO NOT SCALE FROM THIS DRAWING. ONLY WRITTEN DIMENSIONS SHALL BE USED. DIMENSIONS AND LEVELS ARE TO BE VERIFIED ON SITE BY THE CONTRACTOR BEFORE COMMENCING ANY WORK. ANY DISCREPANCIES ARE TO BE REPORTED TO THE ENGINEER FOR VERIFICATION. ON ORIGINAL	<table><tr><td>A</td><td>07/2026</td><td>MM</td><td>TR</td><td>PF</td><td>ISSUED FOR INFORMATION</td><td>IFI</td></tr><tr><td>Rev</td><td>Date</td><td>Prepared by</td><td>Checked by</td><td>Approved by</td><td>Consultant Revision Details</td><td>Status</td></tr></table>	A	07/2026	MM	TR	PF	ISSUED FOR INFORMATION	IFI	Rev	Date	Prepared by	Checked by	Approved by	Consultant Revision Details	Status	Client CITY OF CAPE TOWN ISIXEKO SASEKAPA STAD KAAPSTAD Making progress possible. Together.	<table><tr><td>Client Approval</td><td>Date</td></tr><tr><td>Consultant Name</td><td>PR Eng No.</td></tr><tr><td>PAUL FARIA</td><td>20080318</td></tr><tr><td>Consultant Signature</td><td>Date</td></tr></table>	Client Approval	Date	Consultant Name	PR Eng No.	PAUL FARIA	20080318	Consultant Signature	Date	<table><tr><td>Project Title</td><td>VOORTREKKER ROAD CORRIDOR PHASE 1B</td></tr><tr><td>Drawing Title</td><td>EXISTING & PROPOSED WATER LAYOUT SHEET 2 OF 3</td></tr></table>	Project Title	VOORTREKKER ROAD CORRIDOR PHASE 1B	Drawing Title	EXISTING & PROPOSED WATER LAYOUT SHEET 2 OF 3	Client Number CPX.0010465 Scale 1:500 Drawing Number HHO-7504-503-1661 Rev C	14 FLOOR, THE TOWERS SOUTH, 2 HERTZOG BOULEVARD, CAPE TOWN, SOUTH AFRICA, 8001 TEL: +27 21 425 2870 WEB: www.hho.co.za EMAIL: enquiries@hho.co.za
A	07/2026	MM	TR	PF	ISSUED FOR INFORMATION	IFI																										
Rev	Date	Prepared by	Checked by	Approved by	Consultant Revision Details	Status																										
Client Approval	Date																															
Consultant Name	PR Eng No.																															
PAUL FARIA	20080318																															
Consultant Signature	Date																															
Project Title	VOORTREKKER ROAD CORRIDOR PHASE 1B																															
Drawing Title	EXISTING & PROPOSED WATER LAYOUT SHEET 2 OF 3																															

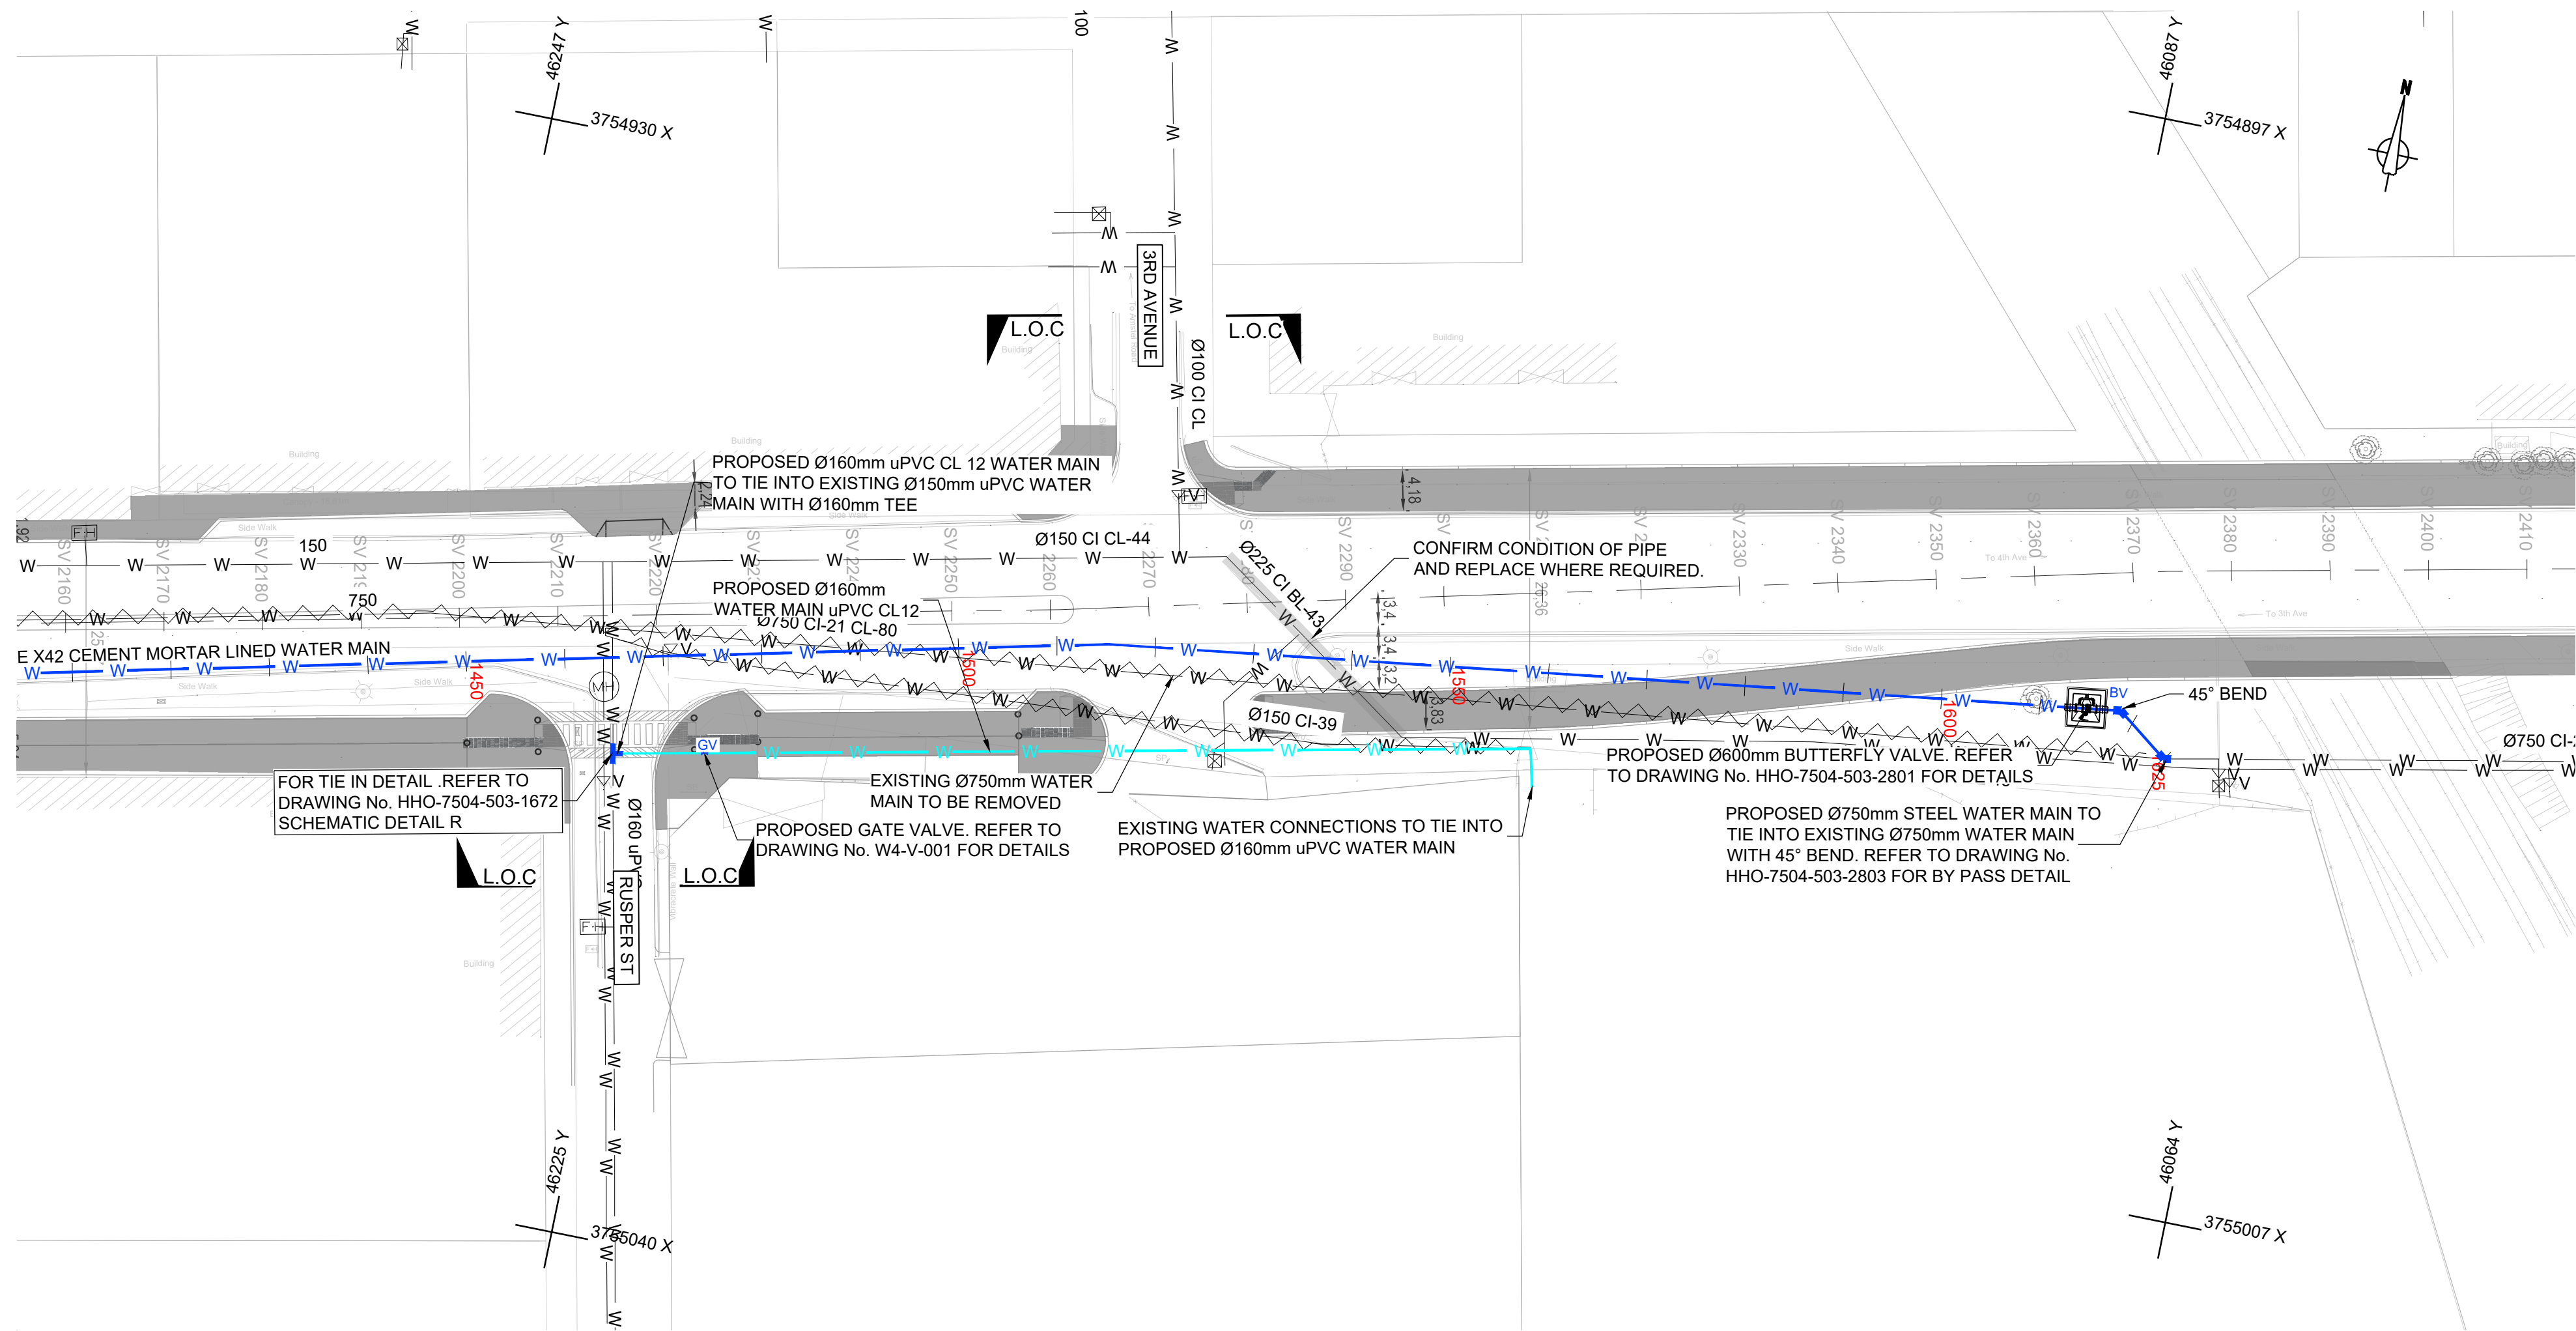

LEGEND			
EXISTING		PROPOSED	
— W —	WATER MAIN	— W —	BULK WATER MAIN
▽ V	WATER VALVE	— W —	WATER MAIN
FR	FIRE HYDRANT	BV	BUTTERFLY VALVE
⊙	WATER MANHOLE	GV	GATE VALVE
WM	WATER METER	AV	AIR VALVE
— W —	WATER MAIN TO BE REMOVED	SCV	SCOUR VALVE
			FIRE HYDRANT

- NOTES:**
- THIS DRAWING SHOULD BE READ IN CONJUNCTION WITH THE PROJECT SPECIFICATIONS AND THE FOLLOWING DRAWINGS:
 - HHO-7504-705-1001 TO 1003 GENERAL LAYOUT: SHEET 1 TO 6
 - HHO-7504-705-1101 TO 1103 TYPICAL CROSS SECTIONS: SHEET 1 TO 4
 - HHO-7504-705-1601 TO 1603 EXISTING & PROPOSED SEWER LAYOUT: SHEET 1 TO 6
 - HHO-7504-705-1621 TO 1623 EXISTING & PROPOSED STORMWATER LAYOUT: SHEET 1 TO 6
 - HHO-7504-705-1641 TO 1646 EXISTING & PROPOSED TELKOM AND ELECTRICAL LAYOUT: SHEET 1 TO 6
 - HHO-7504-505-2001 TO 2003 LONG SECTION 1: PROPOSED DN750 WATER MAIN: SHEET 1 TO 3
 - HHO-7504-505-2011 TO 2012 LONG SECTION 2: PROPOSED DN750 WATER MAIN: SHEET 1 TO 2
 - HHO-7504-505-2801 TO 2805 PROPOSED WATER DETAILS: SHEET 1 TO 5
 - HHO-7504-505-1671 TO 1672 PROPOSED WATER SCHEMATIC DETAILS SHEET 1 TO 2
 - ALL AFFECTED EXISTING WATER CONNECTIONS TO BE REPLACED TO FORMER LOCATIONS.
 - ASCERTAIN CONDITION OF THE EXISTING WATER MAIN / CUT INTO EXISTING WATER MAIN WITH NEW TEE IF REQUIRED.

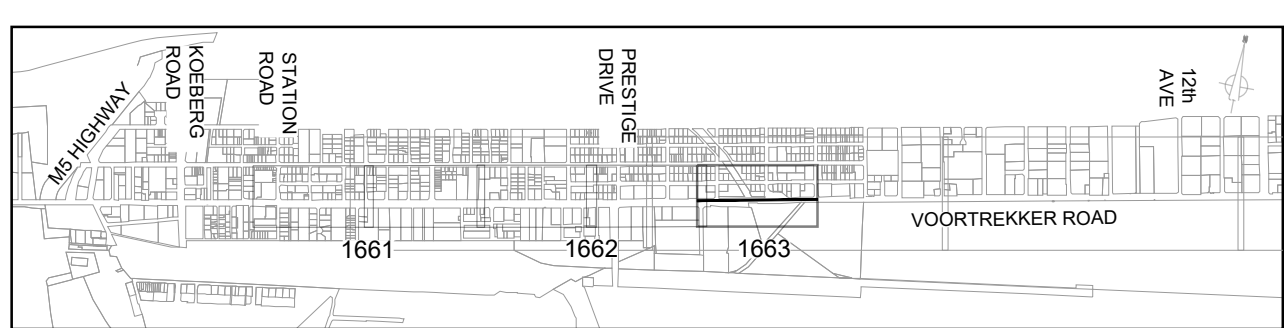


KEY PLAN

FOR INFORMATION
PURPOSES ONLY

THIS DOCUMENT HAS BEEN PREPARED IN ACCORDANCE WITH THE SCOPE OF HHO'S APPOINTMENT. HHO ACCEPTS NO LIABILITY FOR ANY USE OF THIS DOCUMENT OTHER THAN BY ITS CLIENT AND ONLY FOR THE PURPOSES FOR WHICH IT WAS PREPARED AND PROVIDED. © HHO 2018

DO NOT SCALE FROM THIS DRAWING. ONLY WRITTEN DIMENSIONS SHALL BE USED. DIMENSIONS AND LEVELS ARE TO BE VERIFIED ON SITE BY THE CONTRACTOR BEFORE COMMENCING ANY WORK. ANY DISCREPANCIES ARE TO BE REPORTED TO THE ENGINEER FOR VERIFICATION.

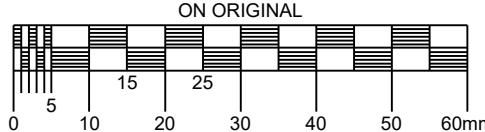

Rev	Date	Prepared by	Checked by	Approved by	ISSUED FOR INFORMATION	Consultant Revision Details	Status
A	07/2026	MM	TR	PF	ISSUED FOR INFORMATION		IFI



Client Approval	Date
Consultant Name	PR Eng No.
PAUL FARIA	20080318
Consultant Signature	Date

Project Title	VOORTREKKER ROAD CORRIDOR PHASE 1B
Drawing Title	EXISTING & PROPOSED WATER LAYOUT SHEET 3 OF 3

Client Number	CPX.0010465
Scale	1:500
Drawing Number	HHO-7504-503-1661
Rev	C

14 FLOOR, THE TOWERS SOUTH,
2 HERTZOG BOULEVARD,
CAPE TOWN, SOUTH AFRICA,
8001

TEL: +27 21 425 2870
WEB: www.hho.co.za
EMAIL: enquiries@hho.co.za